




SURFACE WATER NETWORK: SC-1.000 - SC-1.017

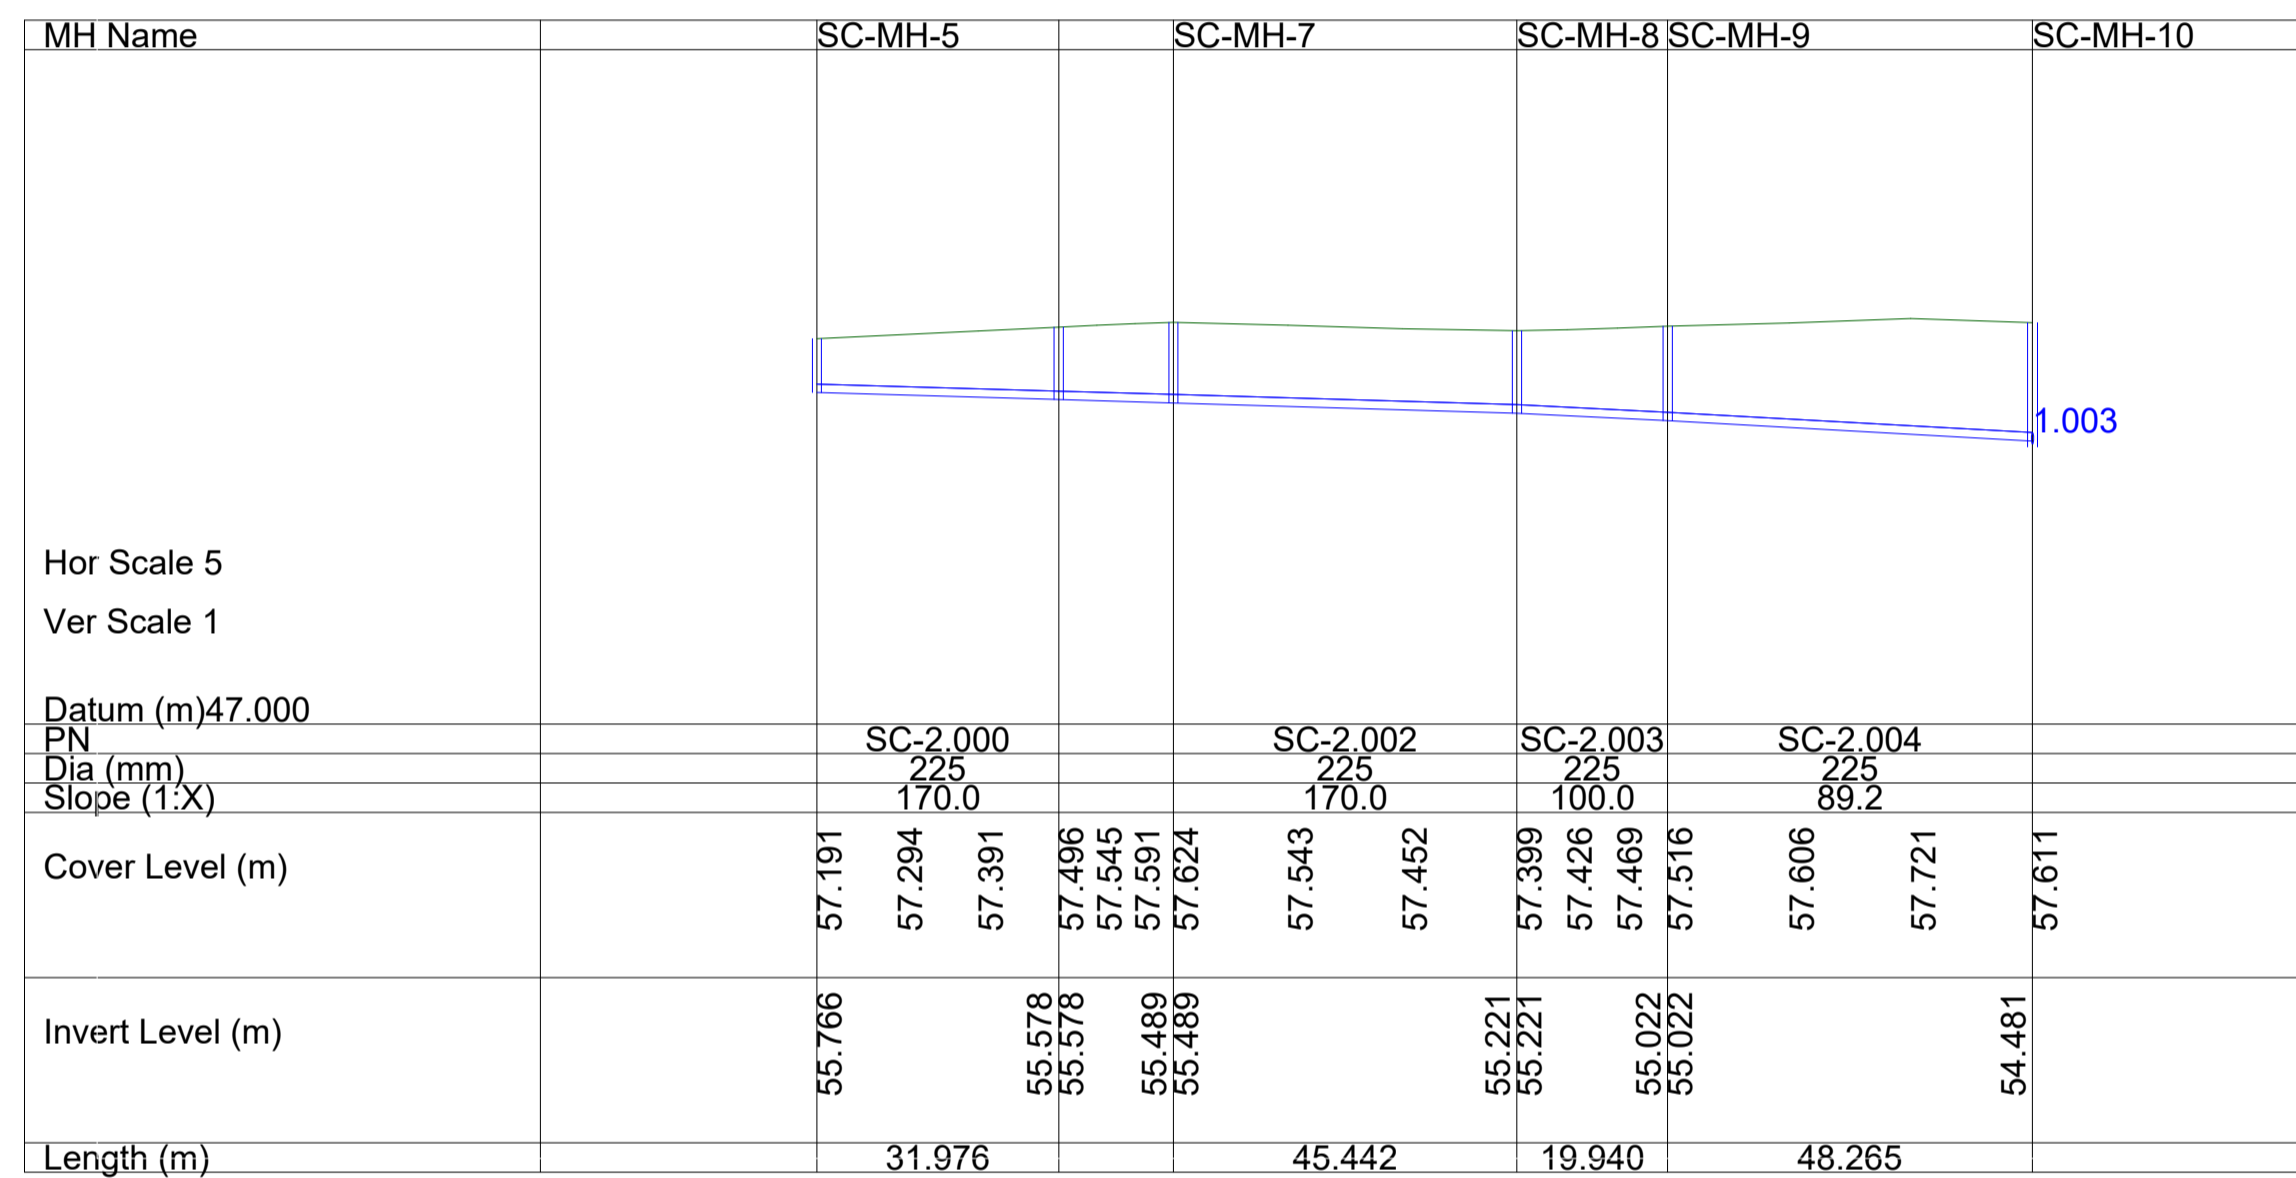


SURFACE WATER NETWORK: SC-2.000 - SC-2.004

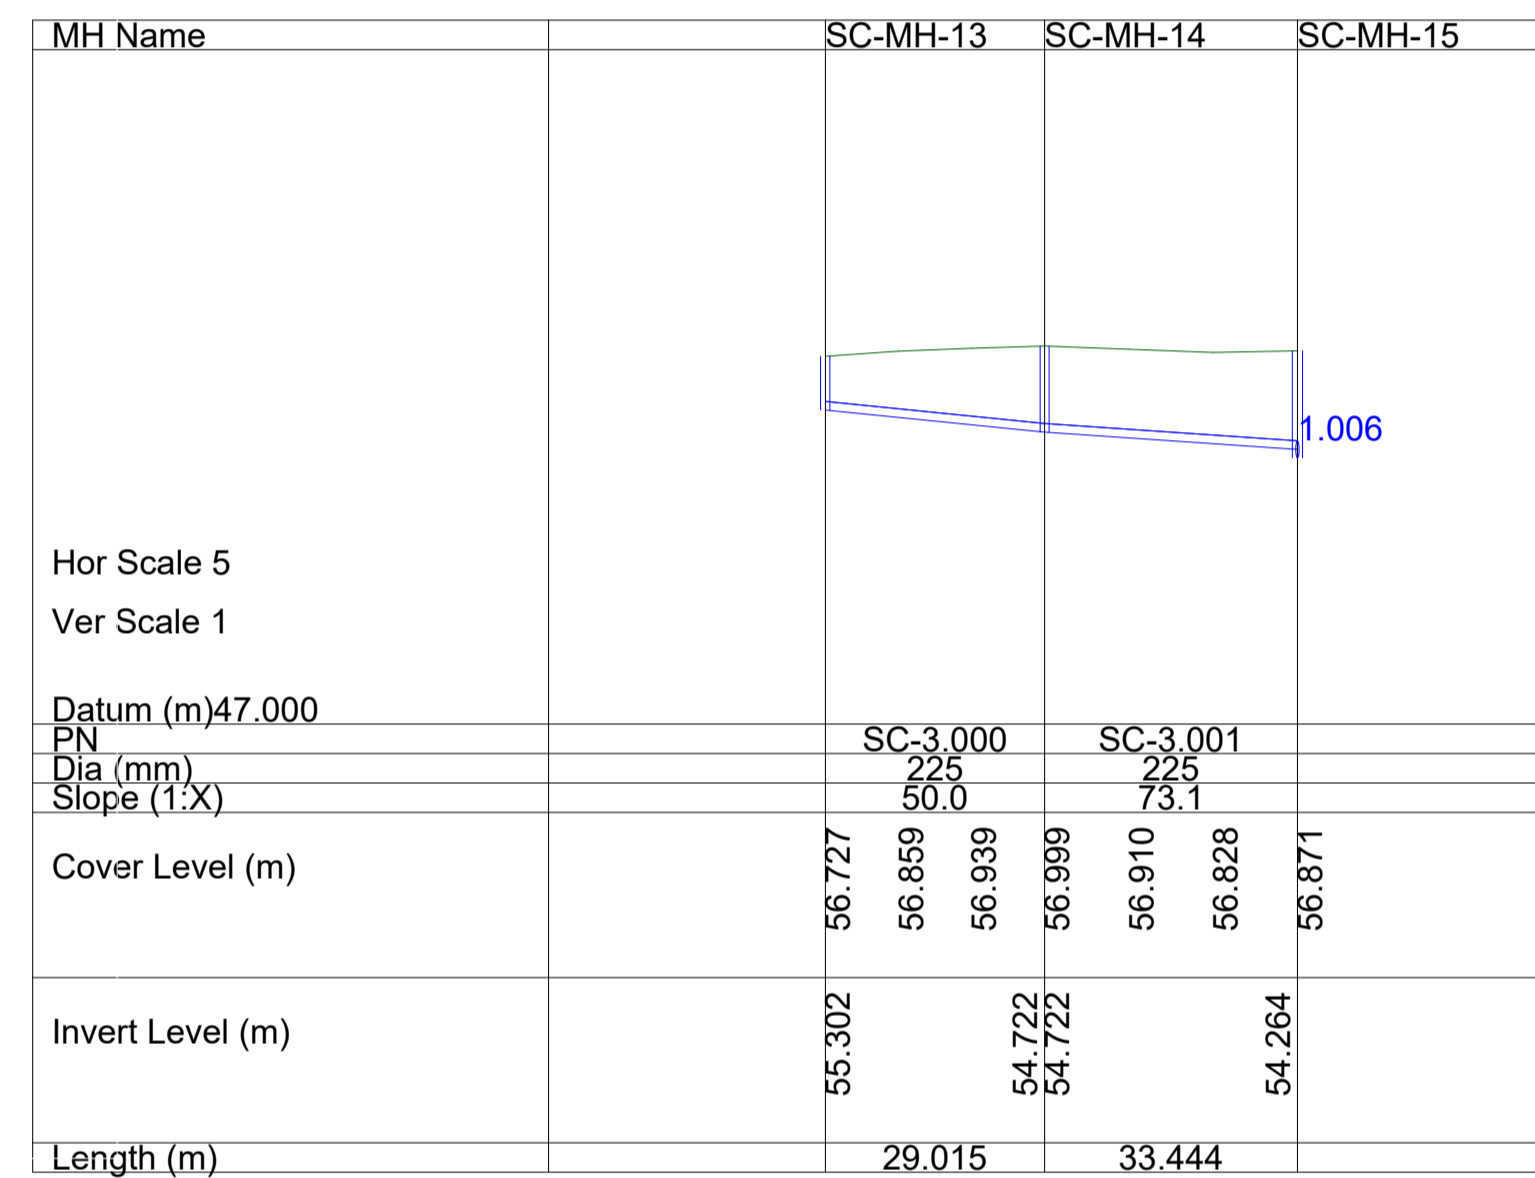

SURFACE WATER NETWORK: SC-3.000 - SC-3.001

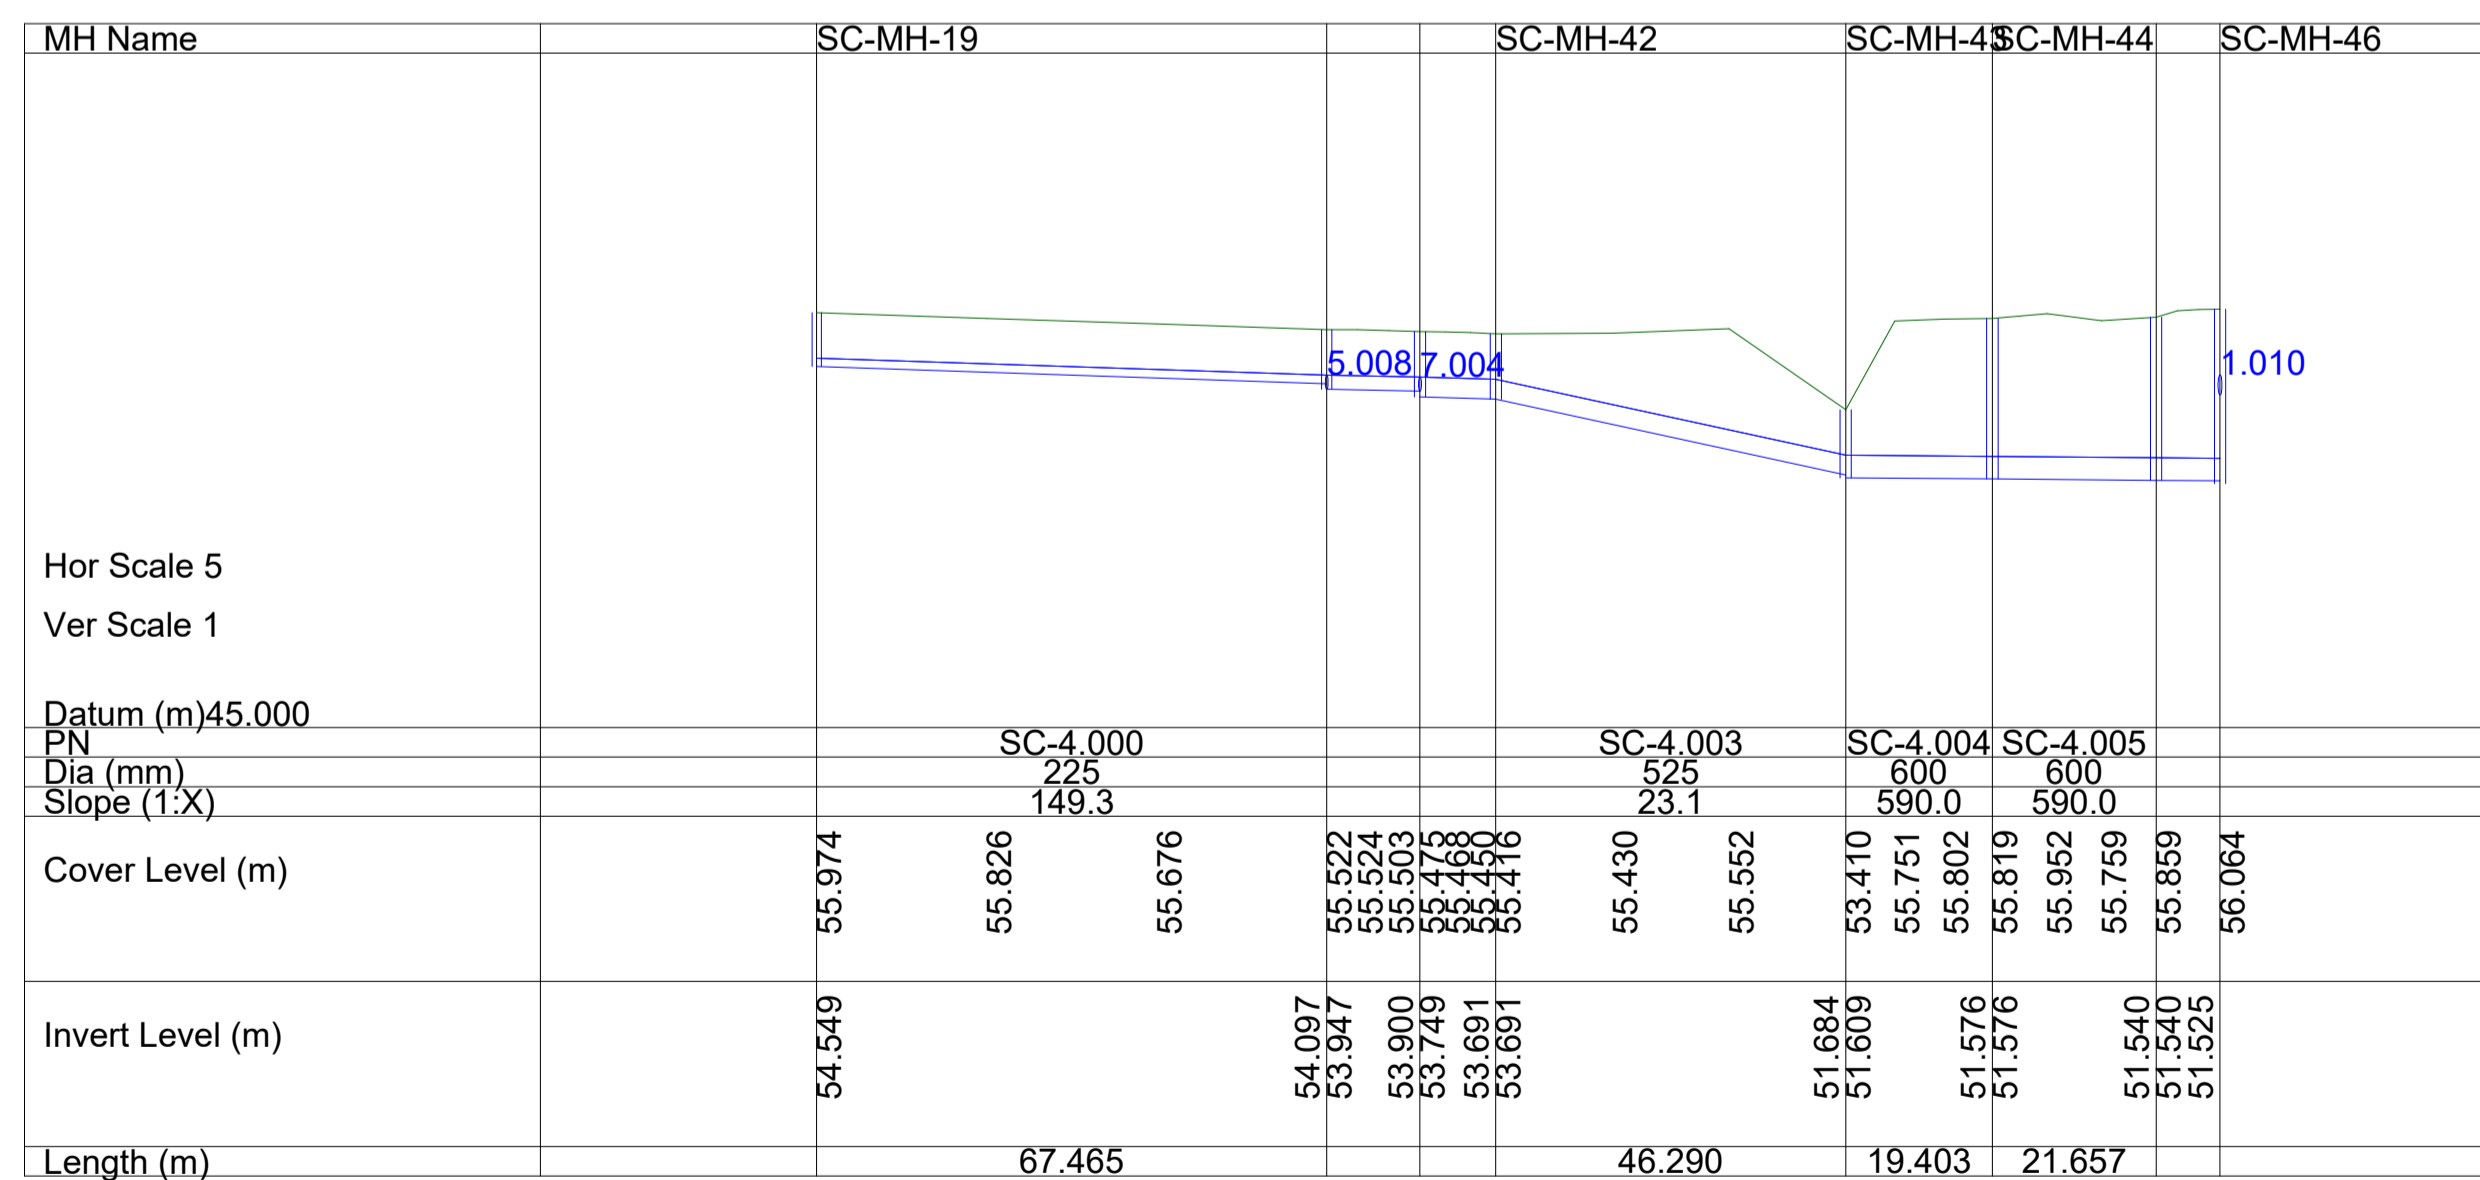

SURFACE WATER NETWORK: SC-4.000 - SC-4.006

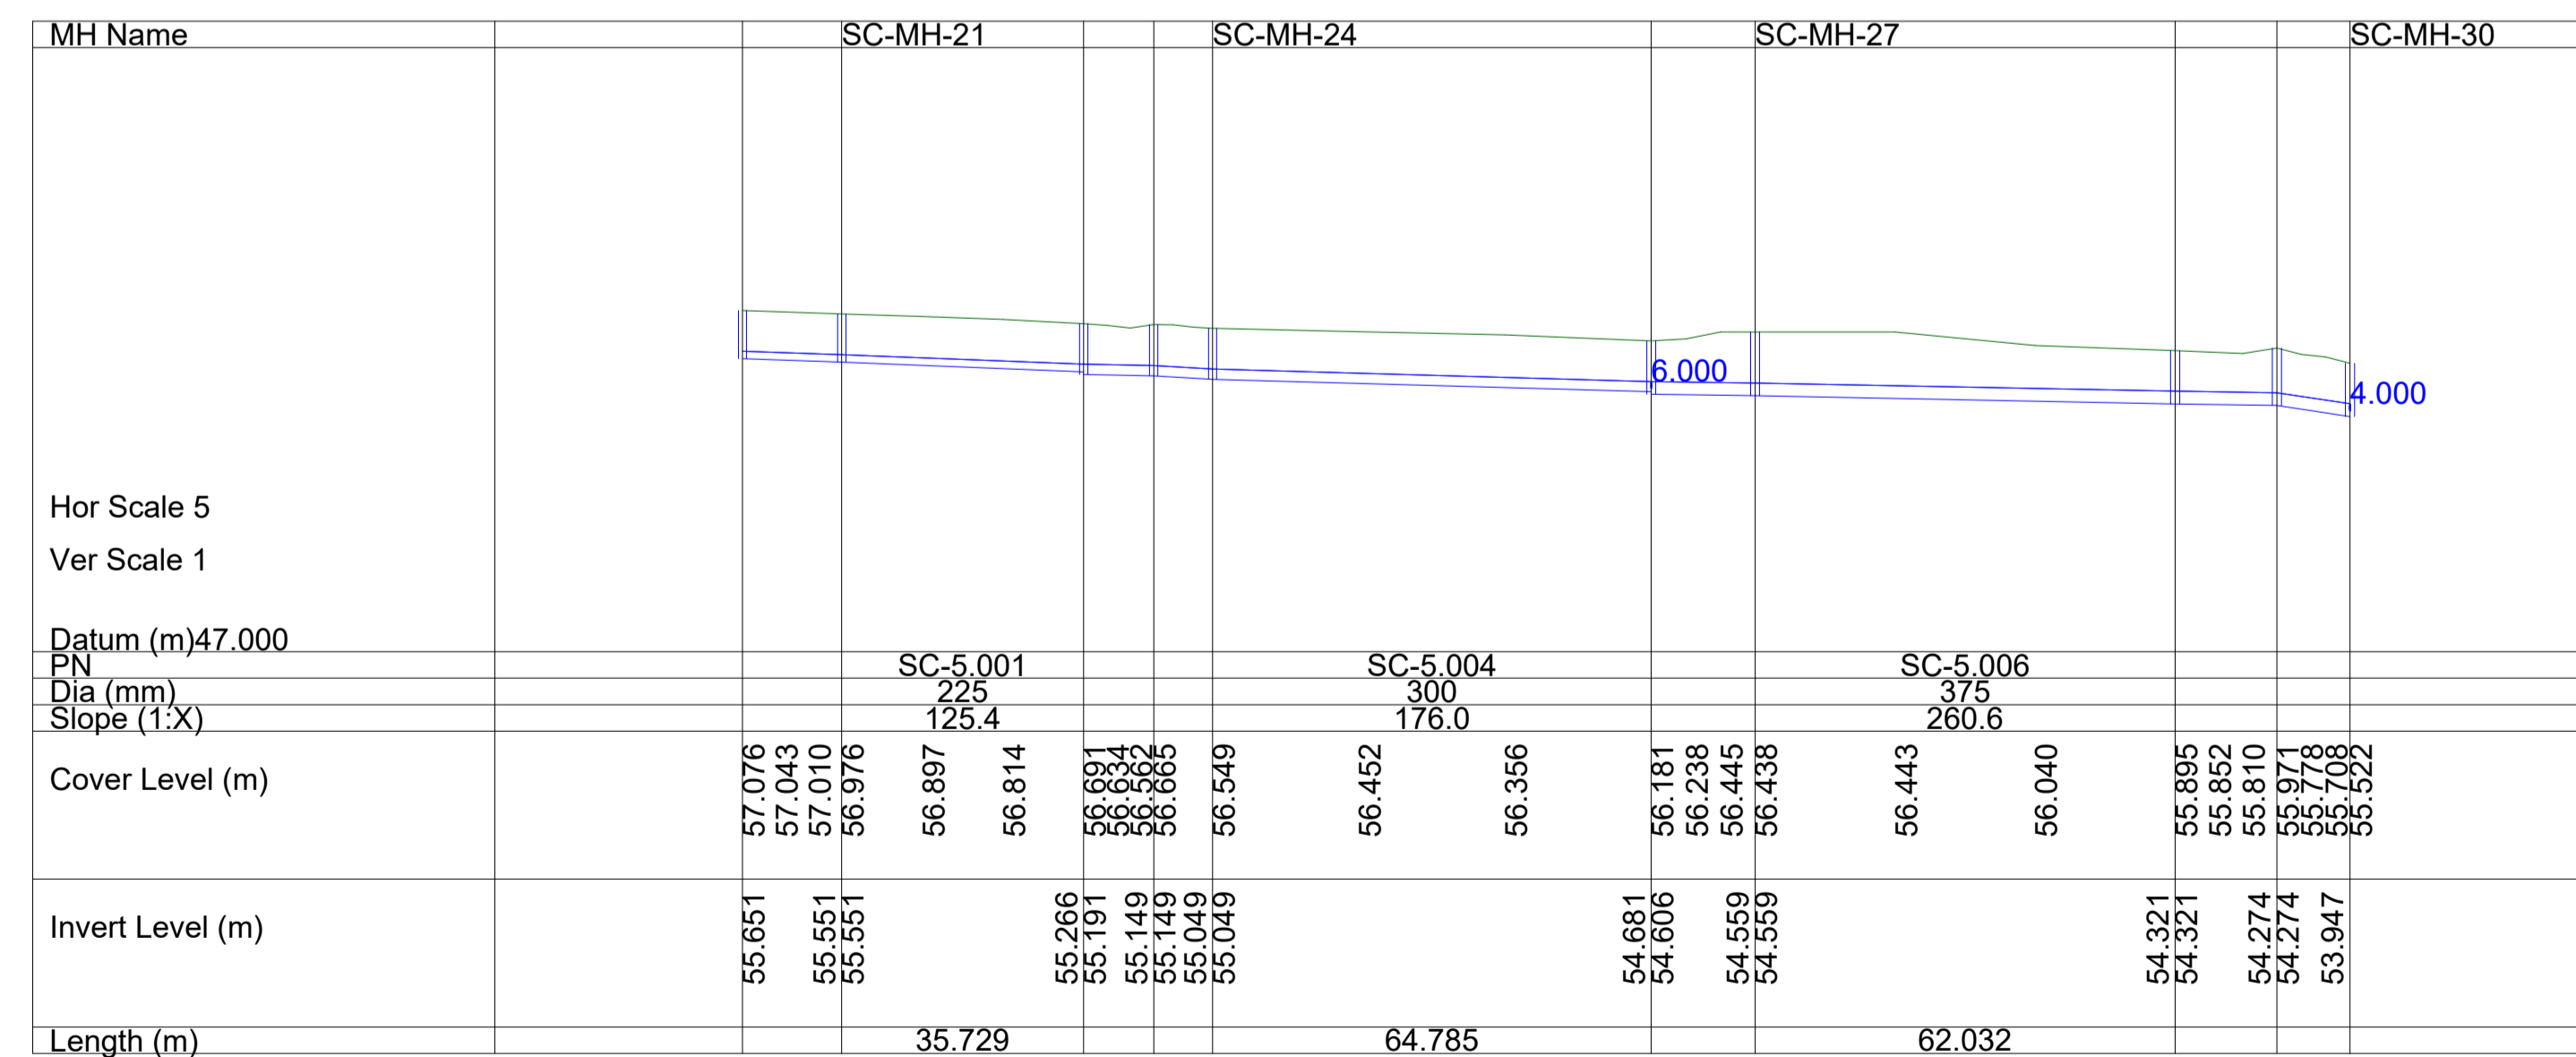

SURFACE WATER NETWORK: SC-5.000 - SC-5.008

**NOTES**  
 1. ALL SURFACE WATER INFRASTRUCTURE TO BE INSTALLED IN ACCORDANCE WITH THE GDSDS AND THE GREATER DUBLIN REGION CODE OF FOR DRAINAGE WORKS.


**REFERENCE NOTE**  
 REFER TO DWG. NO. S665-OCSC-1C-XX-DR-C-0500 FOR MASTERPLAN DRAINAGE LAYOUT AND DWG. S665-OCSC-1C-XX-DR-C-0501-0520 FOR DETAILED DESIGN

**PLANNING DRAWING.**  
 NOT FOR CONSTRUCTION.  
 ALL LEVELS GIVEN ARE RELATIVE TO ORDNANCE DATUM.  
 THIS DRAWING HAS BEEN ISSUED FOR INFORMATION PURPOSES ONLY AND MUST NOT BE USED FOR CONSTRUCTION UNDER ANY CIRCUMSTANCES

- FOR SETTING OUT REFER TO ARCHITECT'S DRAWINGS.
- THIS DRAWING TO BE READ IN CONJUNCTION WITH ALL OTHER ARCHITECTURAL AND ENGINEERING DRAWINGS AND ALL OTHER RELEVANT DRAWINGS AND SPECIFICATIONS.
- DO NOT SCALE THIS DRAWING. USE FIGURED DIMENSIONS ONLY.
- NO PART OF THIS DOCUMENT MAY BE REPRODUCED OR TRANSMITTED IN ANY FORM OR STORED IN ANY RETRIEVAL SYSTEM OF ANY NATURE WITHOUT THE WRITTEN PERMISSION OF O'CONNOR SUTTON CRONIN AS COPYRIGHT HOLDER EXCEPT AS AGREED FOR USE ON THE PROJECT FOR WHICH THE DOCUMENT WAS ORIGINALLY ISSUED.

Rev No.	Date	Revision Note	Drn by	Chkd by
P01	19.08.22	SUITABLE FOR PLANNING	EH	MK

Rev No.	Date	Revision Note	Drn by	Chkd by

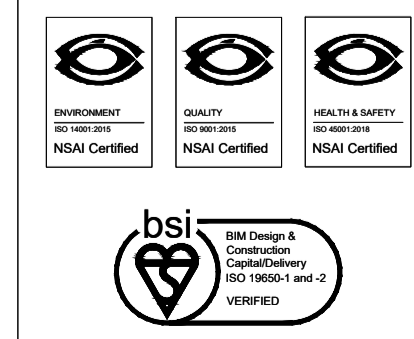

Head Office,  
 9 Prussia Street,  
 Dublin 7,  
 D07 KT57  
 TEL +353 (0)1 8682000  
 e: contactus@ocsc.ie  
 w: www.ocsc.ie  
 Dublin | London | Belfast | Galway | Cork | Birmingham



Client: SKY CASTLE LTD.  
 Project: MOYGADDY CASTLE SHD  
 Title: PROPOSED DRAINAGE NETWORK SURFACE WATER LONGSECTIONS SHEET 1 OF 3  
 Code | Originator | Zone | Level | Type | Role | Number | Status | Revision  
 S665-OCSC-1C-XX-DR-C-0532 | S4 | P01  
 Date: AUG '22 Scale: 1:200 @ A1 Drn by:EH Chkd by:MK Aprvd by:AH